




5000 - OVERALL

4752 - INTERNAL

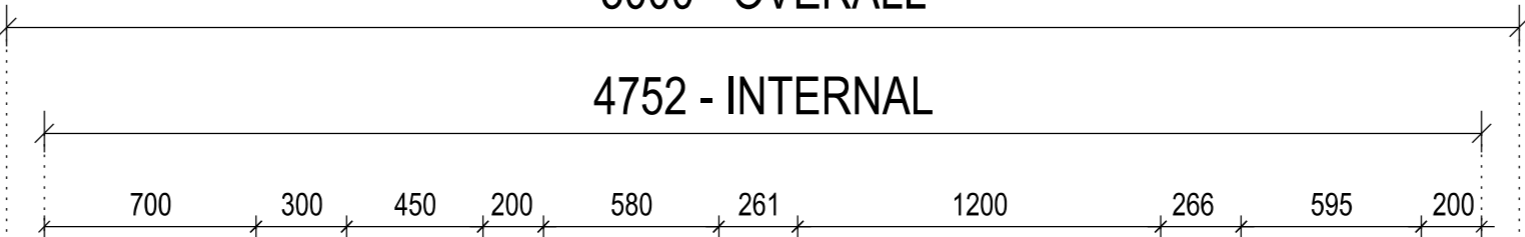

AIR-CONDITIONING CONDENSERS TO BE MOUNTED AT SLAB LEVEL
CONDENSERS TO BE MOUNTED ON TOP OF EACH OTHER

INTERNAL SHEETING
COLORBOND FLAT SHEET "SURFMIST"



 
LANDING BY OTHERS

METAL CLAD DOORS
"PALE EUCALYPT"
SEE DP01 FOR DETAILS

EXTERNAL SHEETING
COLORBOND PANELRIB
"PALE EUCALYPT"


FIRE RATED SHEETING

D. 820
2450




D. 820
2450

698

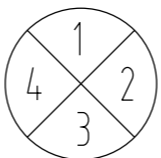

AS VINYL

 

D. 820
2100

LANDING BY OTHERS

3252 - INTERNAL

3500 - OVERALL



GENERAL FLOOR PLAN
PUMP STATION SWITCHROOM



GROUND TO FFL = xxxmm
FFL TO CEILING = 2900mm
CLEARANCE UNDER = xxxmm

ALL LANDING, STAIRS AND
HANDRAILINGS BY OTHERS

MCC
3904 L x 650 W x 2240 H (2190 kg)

PLC SWITCHBOARD
1200 L x 450 W x 2250 H (160kg)

BATT. CHARGER
672 L x 540 W x 2225 H (220kg)

METER

SWITCHROOM WEIGHTS:
SWITCHROOM - 4,700kg
EQUIPMENT - 3,000kg
SUB-FLOOR - xxxkg
TOTAL - xx,xxxkg

ROCKHAMPTON REGIONAL COUNCIL

APPROVED PLANS

These plans are approved subject to the current conditions of approval associated with
Development Permit No.: D/53-2020
Dated: 1 July 2020

THIS DRAWING AND ANY INFORMATION CONTAINED WITHIN REMAINS THE INTELLECTUAL PROPERTY OF A.C.E.P.T. PTY. LTD. AND SHALL NOT BE USED FOR ANY PURPOSES WITHOUT PRIOR WRITTEN AUTHORITY FROM A.C.E.P.T. PTY. LTD. UNAUTHORIZED USE OF THIS DRAWING OR INFORMATION CONTAINED WITHIN SHALL BE DEEMED TO BE A BREACH OF COPYRIGHT.

A.C.E.P.T. Pty. Ltd.
A.B.N. 12085669950
australian customised equipment protection technology
5 Combarton Street, Brendale. QLD 4500 p. (61)7 3205 9771 f. (61)7 3205 9774
P.O. BOX 325, The Gap. QLD 4061 www.acept.com.au

Issue	Date	Description	Drawn	Client
A	22-04-20	INITIAL ISSUE: ISSUED FOR DESIGN APPROVAL	TC	
B	05-05-20	AMENDED TO CLIENTS COMMENTS	TC	



RRC - HADGRAFT ST
SEWERAGE PUMP STATION

Scale at A3	1:20	Drawing Title	FLOOR PLAN
Date	22/04/20		
Drawn	T CLEARY		GENERAL ARRANGEMENT FOR SWITCHROOM
Checked	-		
Project No.	3000	Drawing Number	AP01B


ROCKHAMPTON REGIONAL COUNCIL

APPROVED PLANS


These plans are approved subject to the current conditions of approval associated with

Development Permit No.: D/53-2020

Dated: 1 July 2020

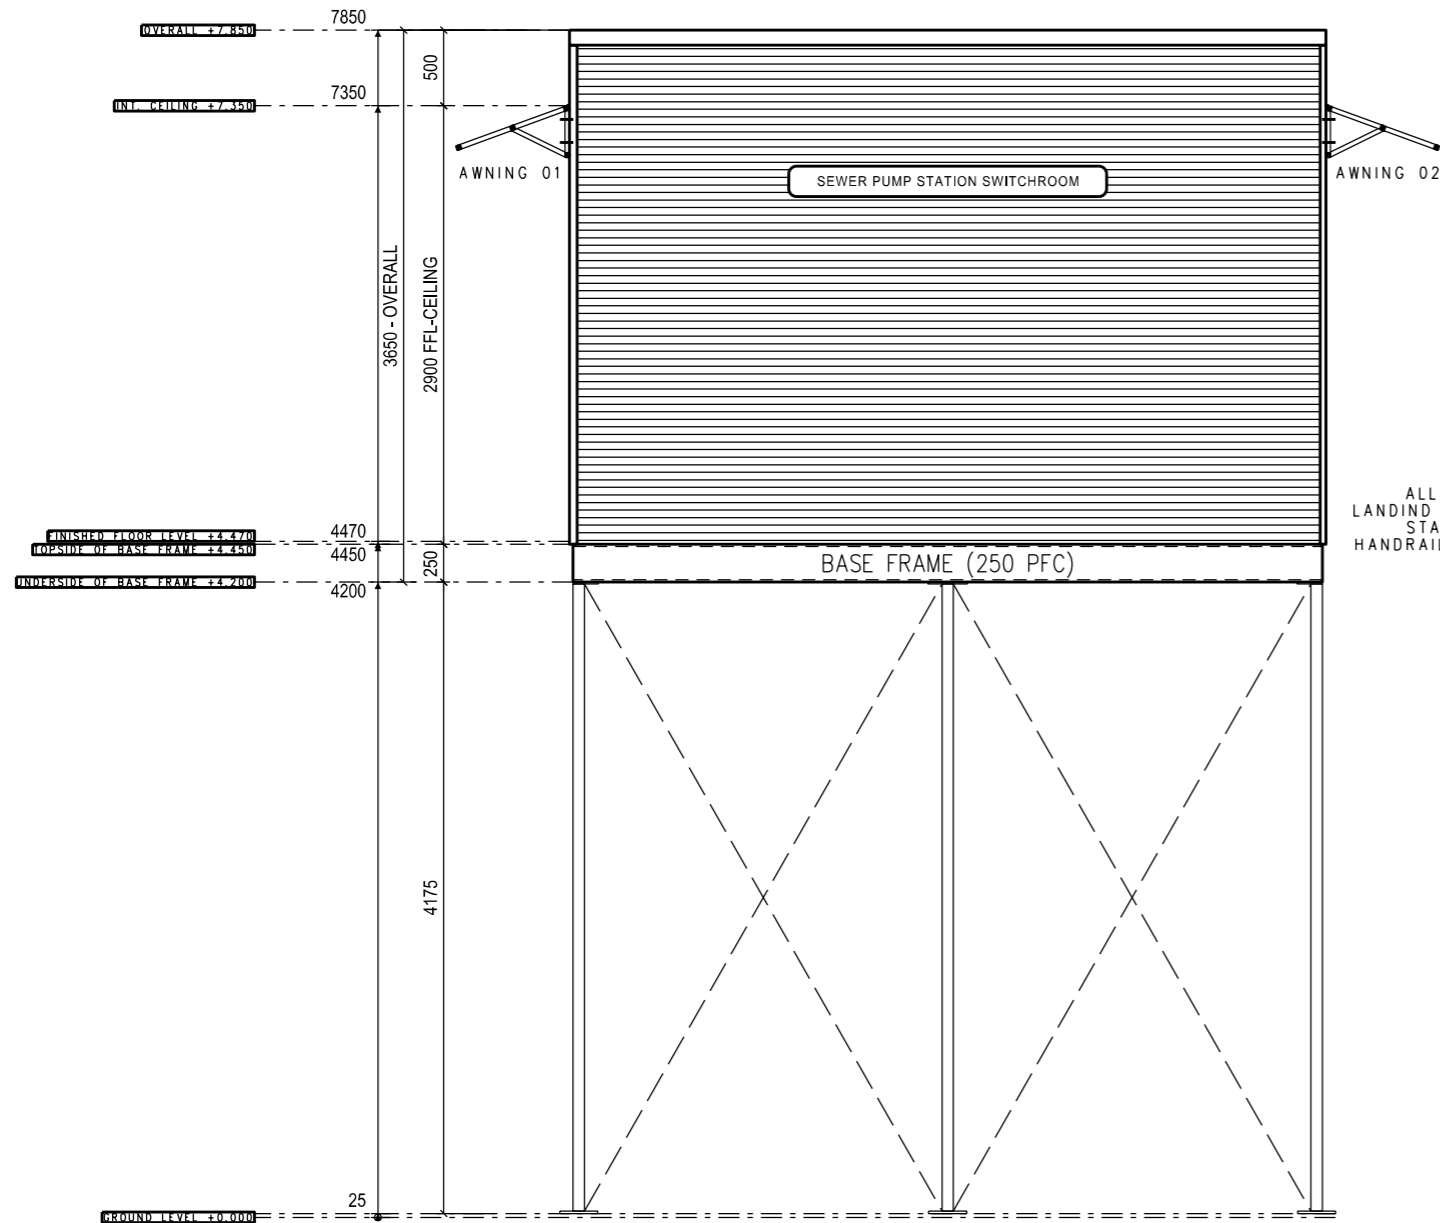

ALL LANDINGS,
LANDING SUPPORT POSTS
STAIR WAYS &
HANDRAILING BY OTHERS

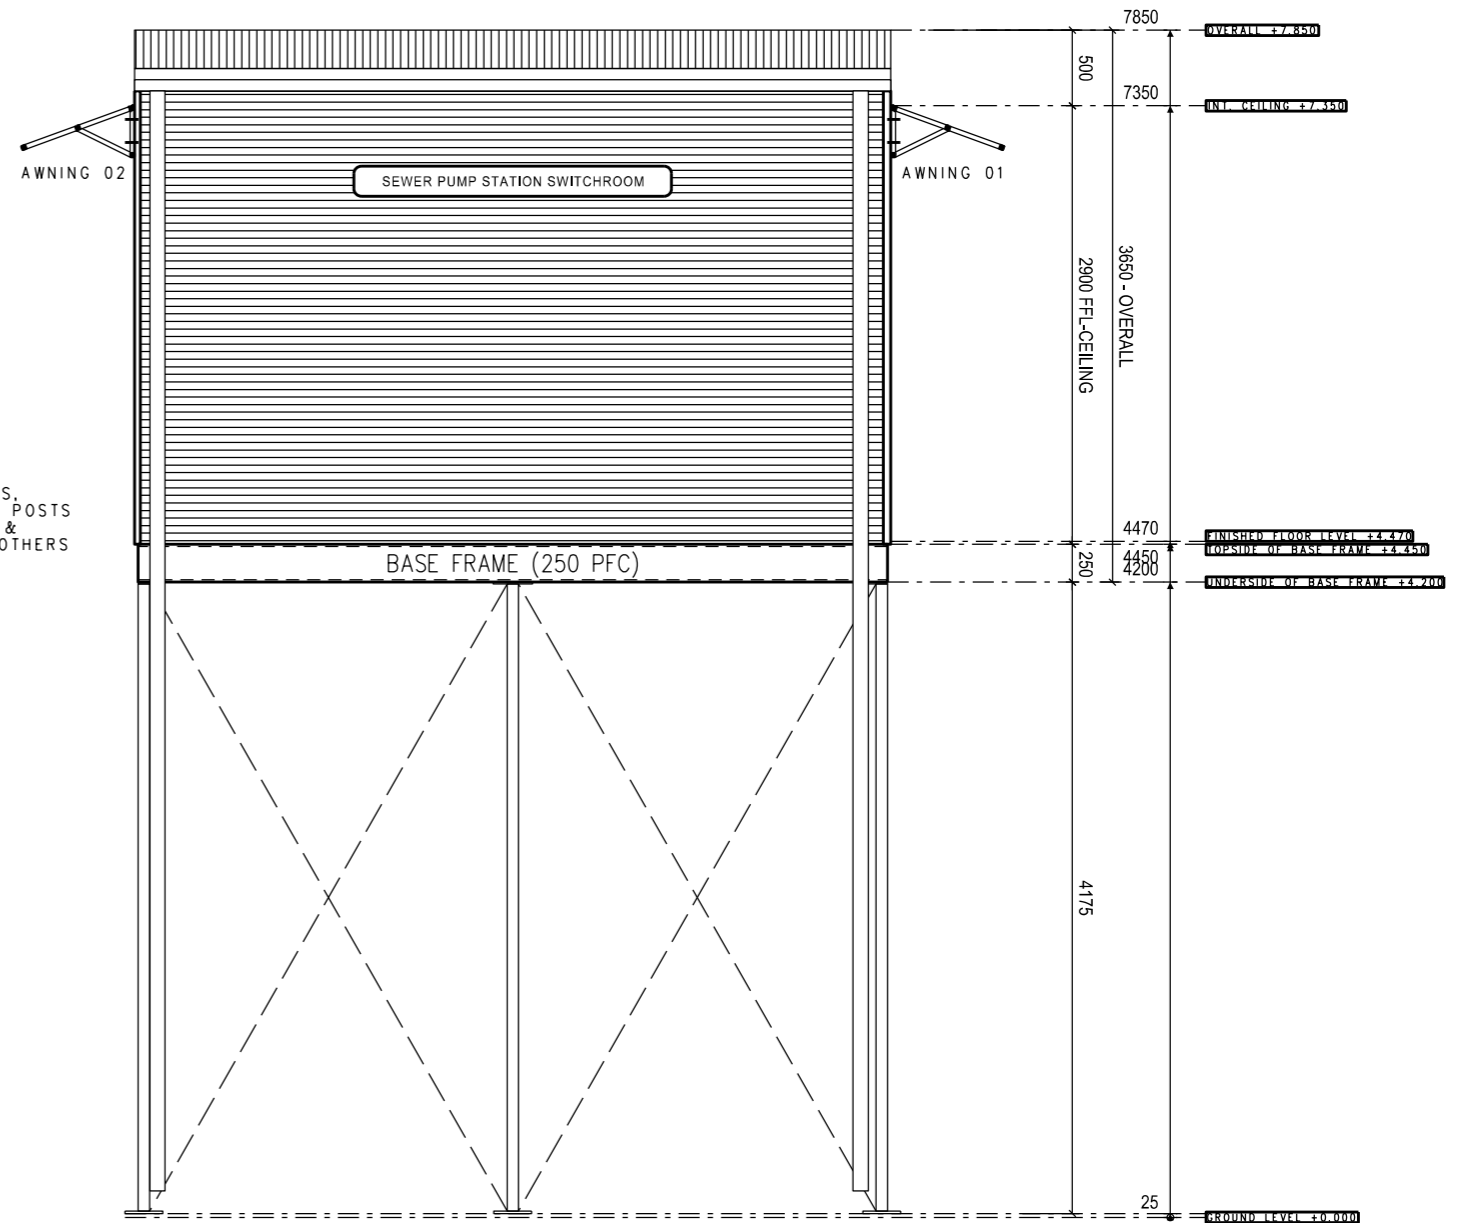

THIS DRAWING AND ANY INFORMATION CONTAINED WITHIN REMAINS THE INTELLECTUAL PROPERTY OF A.C.E.P.T. PTY. LTD. AND SHALL NOT BE USED FOR ANY PURPOSES WITHOUT PRIOR WRITTEN AUTHORITY FROM A.C.E.P.T. PTY. LTD. UNAUTHORIZED USE OF THIS DRAWING OR INFORMATION CONTAINED WITHIN SHALL BE DEEMED TO BE A BREACH OF COPYRIGHT.

A.C.E.P.T. Pty. Ltd.
A.B.N. 12085669950
australian customised equipment protection technology
5 Combarton Street, Brendale. QLD 4500 p. (61)7 3205 9774 f. (61)7 3205 9774
P.O. BOX 325, The Gap. QLD 4061 www.acept.com.au

Issue	Date	Description	Drawn	Client
A	05-05-20	INITIAL ISSUE: ISSUED FOR DESIGN APPROVAL	TC	

SJELECTRIC
RCC - HADGRAFT
SEWERAGE PUMP STATION

Scale at A3	1:50	Drawing Title	ELEVATIONS - EXTERNAL - 01
Date	05-05-20		
Drawn	T CLEARY	DETAILS/LAYOUT FOR SWITCHROOM	
Checked	-		
Project No.	3000	Drawing Number	ELE01-1A

This Drawing is the property of A.C.E.P.T. Pty. Ltd and must not be used in any way without written authority.


ROCKHAMPTON REGIONAL COUNCIL

APPROVED PLANS


These plans are approved subject to the current conditions of approval associated with

Development Permit No.: D/53-2020

Dated: 1 July 2020

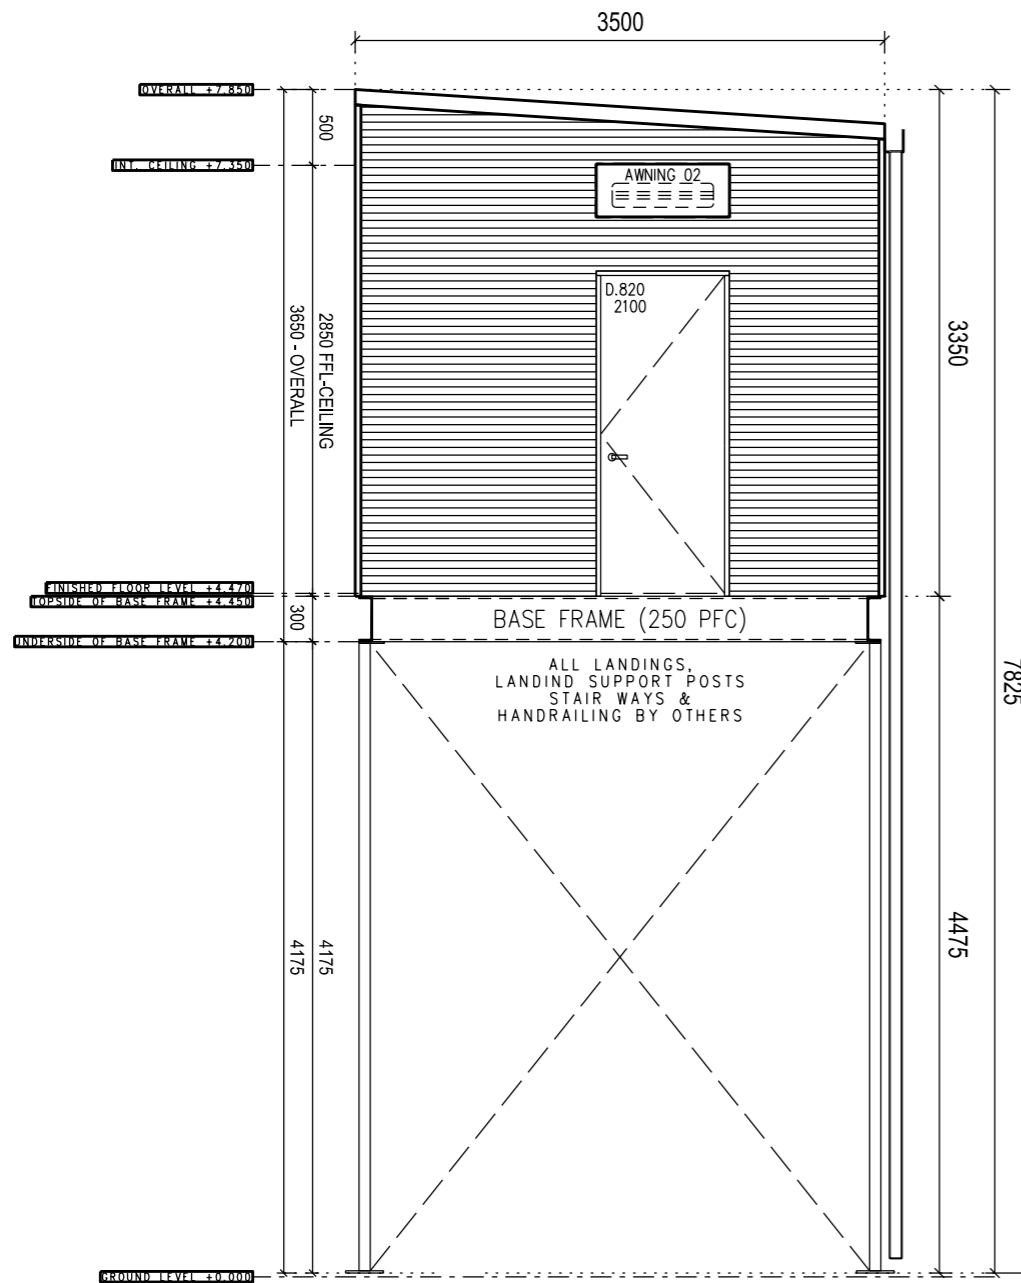

02 - EXTERNAL ELEVATION

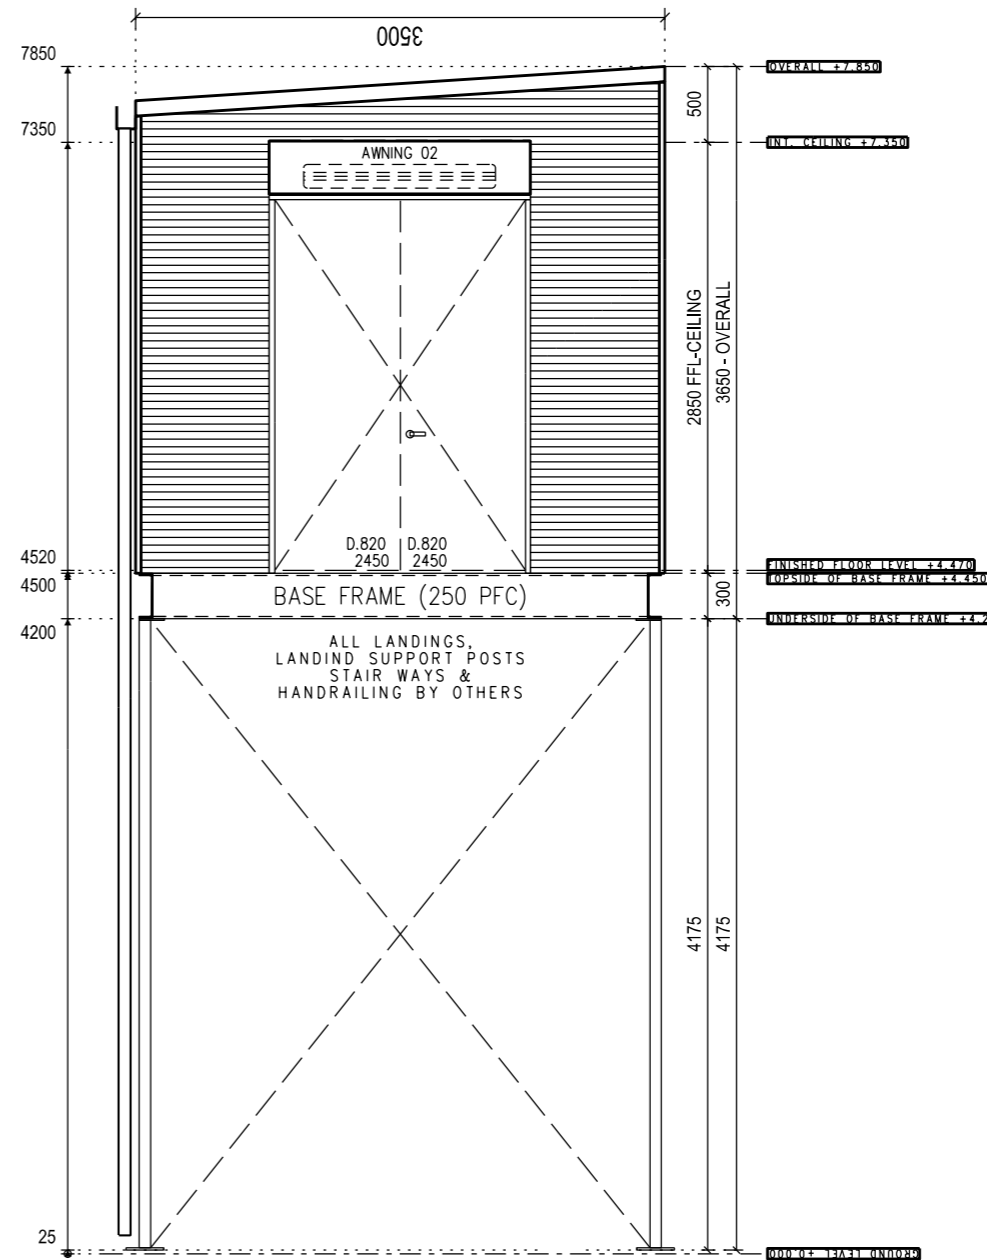

04 - EXTERNAL ELEVATION

THIS DRAWING AND ANY INFORMATION CONTAINED WITHIN REMAINS THE INTELLECTUAL PROPERTY OF A.C.E.P.T. PTY. LTD. AND SHALL NOT BE USED FOR ANY PURPOSES WITHOUT PRIOR WRITTEN AUTHORITY FROM A.C.E.P.T. PTY. LTD. UNAUTHORIZED USE OF THIS DRAWING OR INFORMATION CONTAINED WITHIN SHALL BE DEEMED TO BE A BREACH OF COPYRIGHT.

A.C.E.P.T. Pty. Ltd.
 A.B.N. 12085669950
 australian customised equipment protection technology
 5 Combarton Street, Brendale. QLD 4500 p. (61)7 3205 9771 f. (61)7 3205 9774
 P.O. BOX 325, The Gap. QLD 4061 www.acept.com.au

Issue	Date	Description	Drawn	Client
A	05-05-20	INITIAL ISSUE: ISSUED FOR DESIGN APPROVAL	TC	

SJELECTRIC
 RCC - HADGRAFT
 SEWERAGE PUMP STATION

Scale at A3	N.T.S.	Drawing Title
Date	05-05-20	ELEVATIONS - EXTERNAL - 02
Drawn	T CLEARY	DETAILS/LAYOUT FOR SWITCHROOM
Checked	-	
Project No.	3000	Drawing Number
		ELE01-2A

This Drawing is the property of A.C.E.P.T. Pty. Ltd and must not be used in any way without written authority.